


# Annexure II

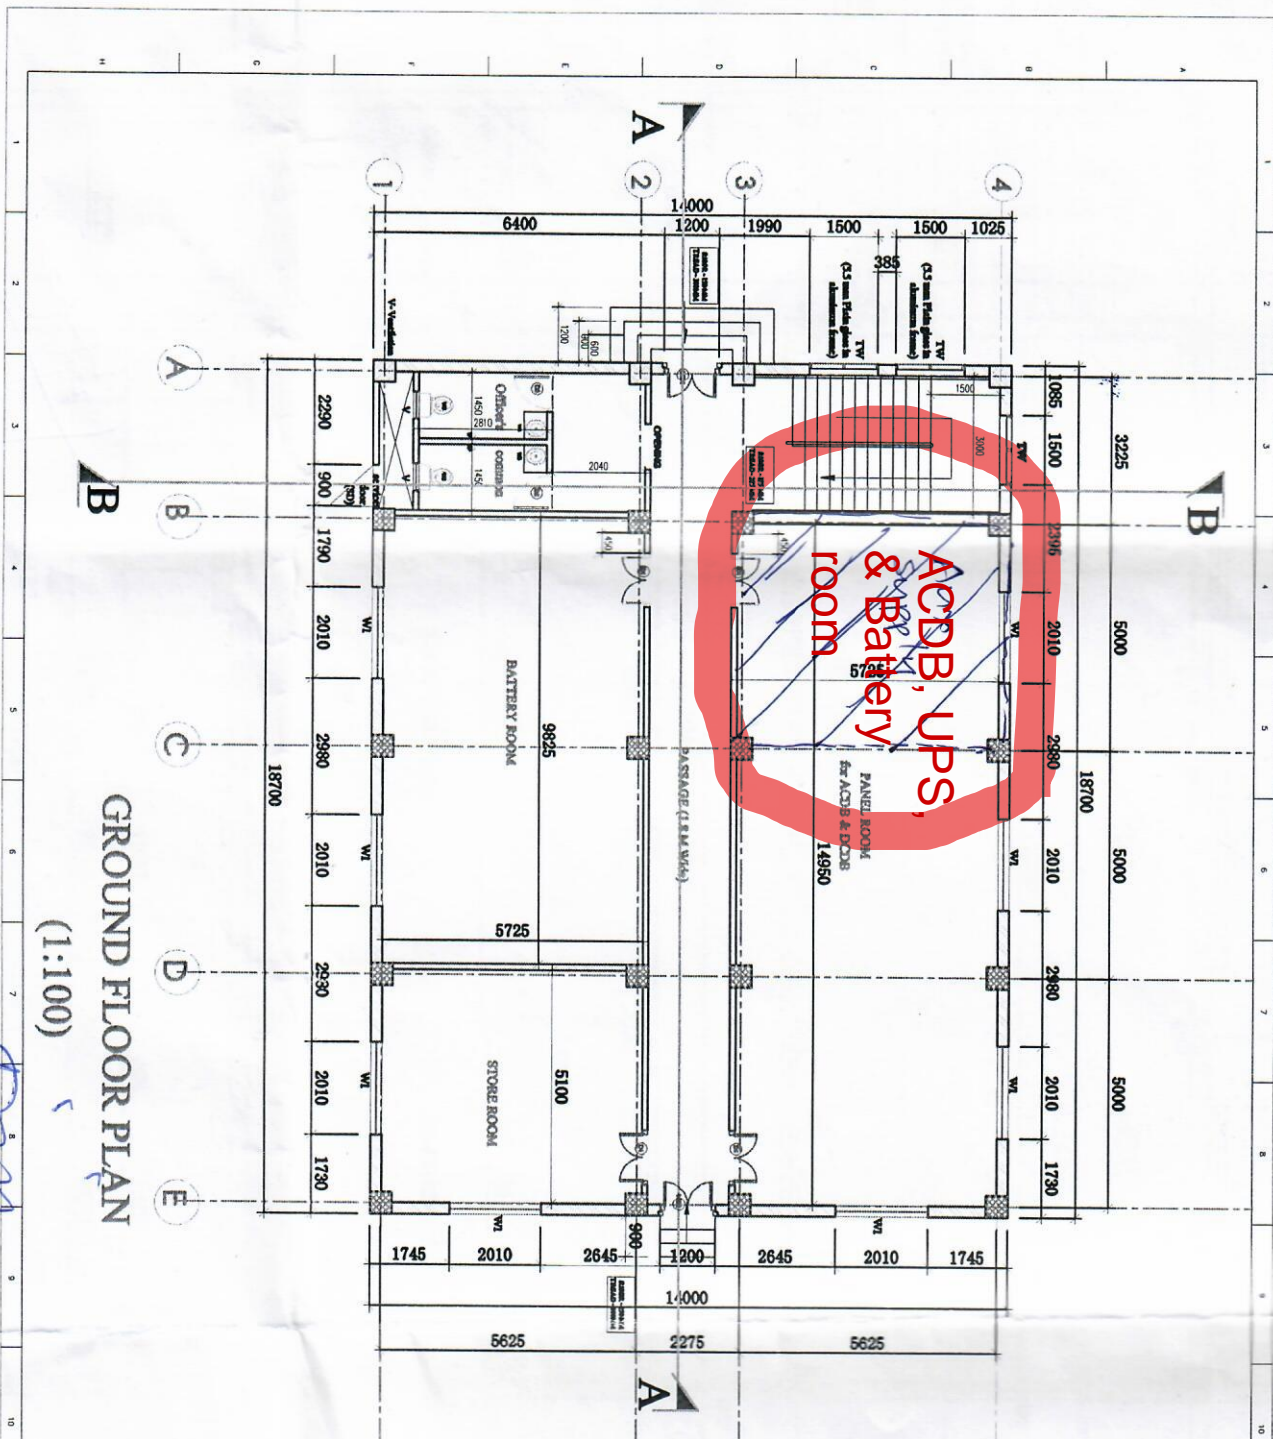

**GROUND FLOOR PLAN**  
(1:100)

Sl.No	Description	Sill level	Size (m)
1	MD1	-	2.44*1.2
2	D1	-	2.44*1.2
3	D2	-	2.1*0.85
4	W1	0.650	1.625*2.010
5	W2	0.650	1.825*1.440
6	RA8T	-	as/ detail
7	Door Rear	-	as/ detail
8	TV	2.600	1.500* 6.050
9	AL. PW	-	5.150* 3.815
10	SD	-	0.700* 1.500
11	V	1.025	0.600* 0.800
12	O	2.175	0.450* 0.450

Allocated space

AS-BUILT

**CLIENT**  
BHUTAN POWER CORPORATION LTD.

**CONSULTANT**  
WAGOCS LIMITED  
A GOVT. OF BHUTAN ENTERPRISE

**CONTRACTOR**  
HYOSUNG

**PROJECT**  
CONTROL ROOM BUILDING  
JANGMEUNG SUBSTATION, BHUTAN

**TITLE**  
ARCHITECTURAL DRAWING

**DATE**  
2023


**PROJECT NO.**  
DWG. NO. BUB-000-000-000-000

**SHEET NO.**  
1 OF 1

**SCALE**  
AS BUILT



2	D1
3	D2
4	W1
5	W2
6	RAB1
7	Duct Rear
8	TW
9	AL. PW
10	SD
11	V
12	O

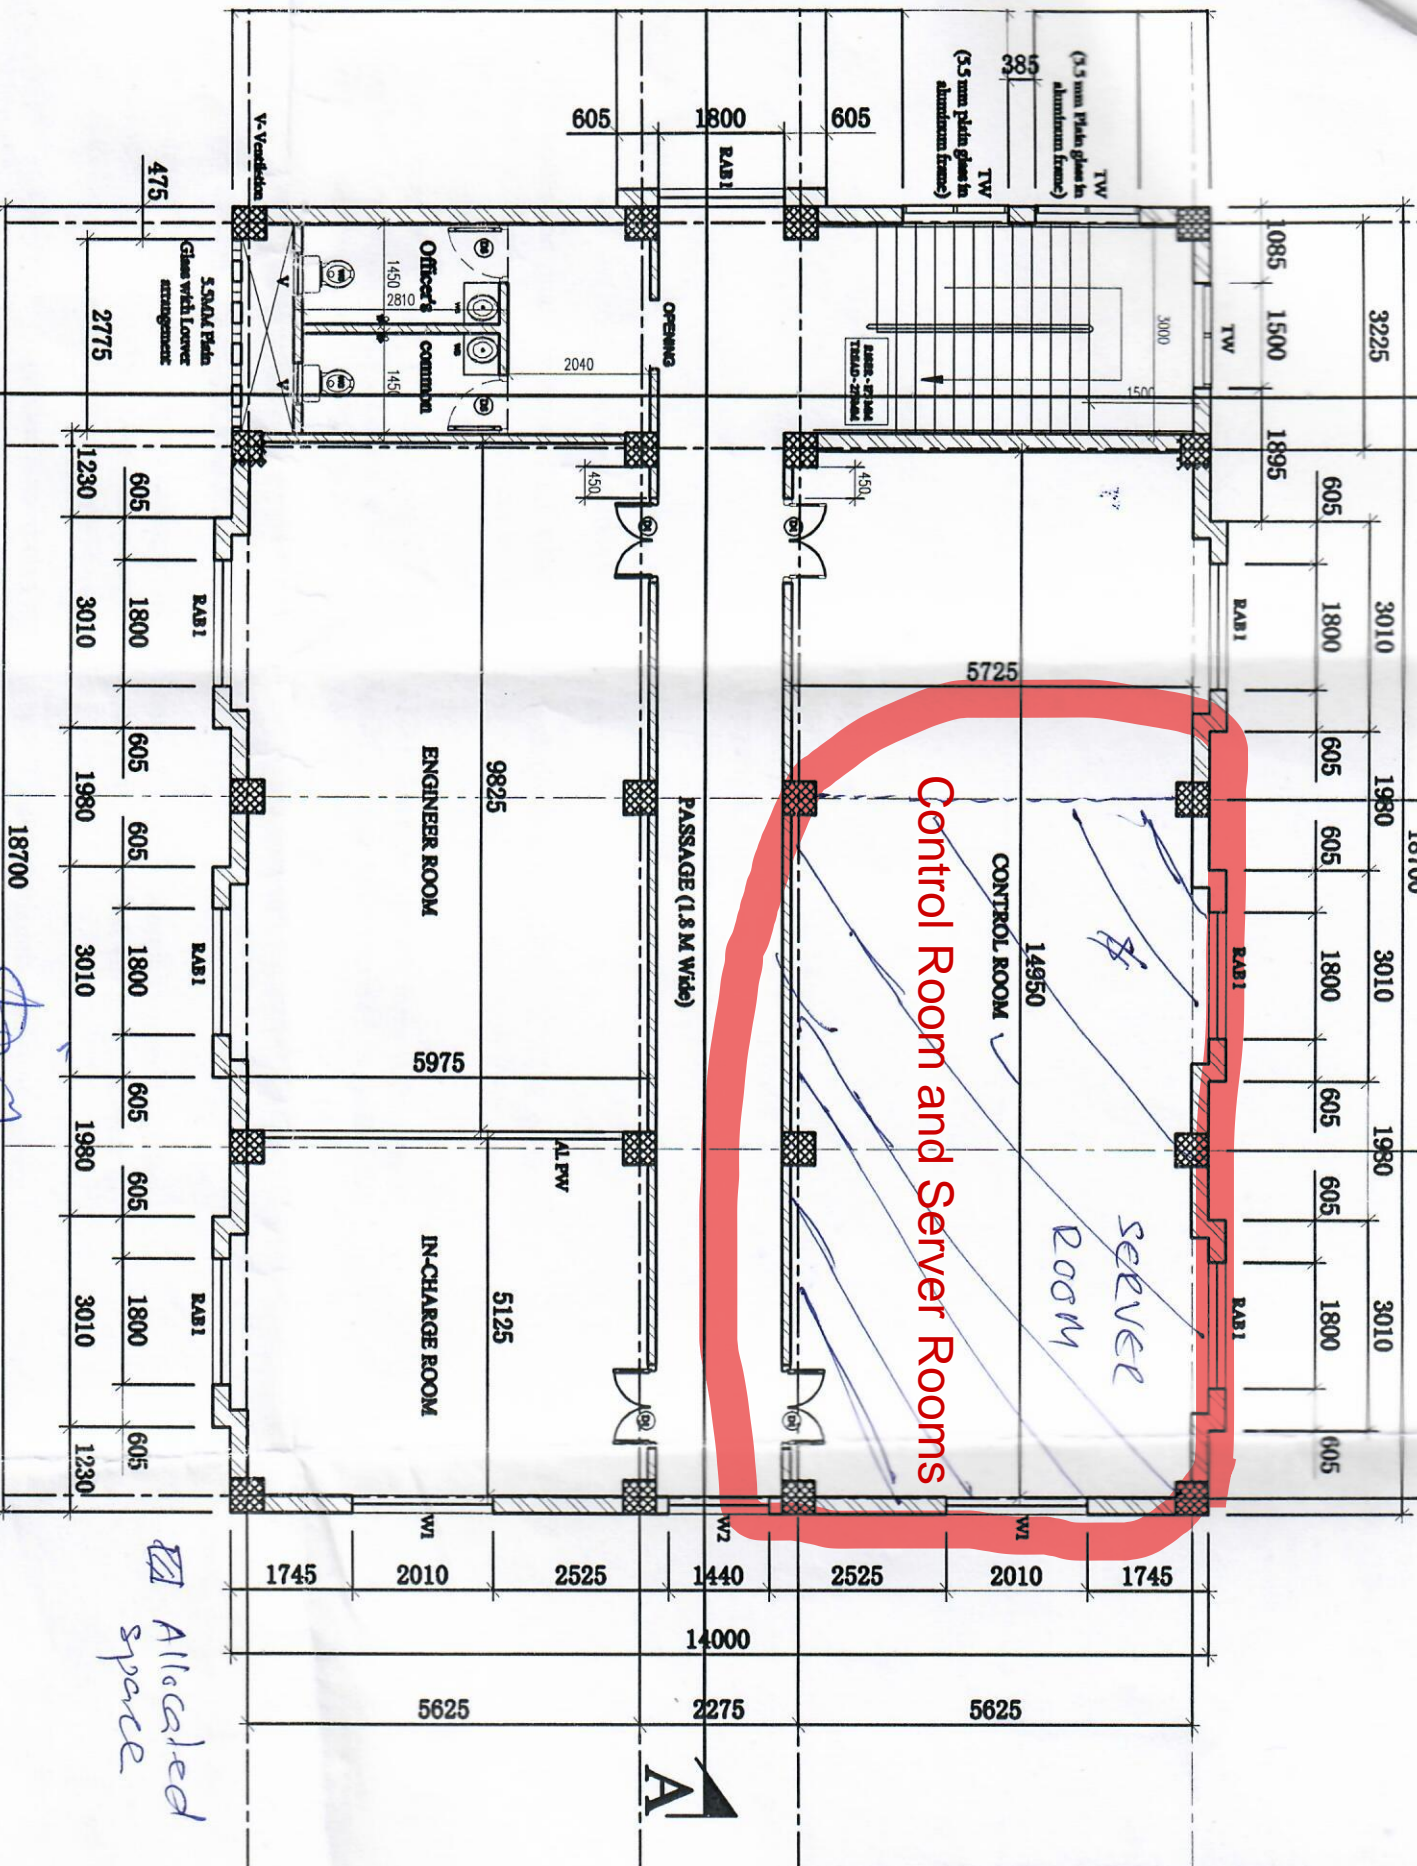

*Allocated space*

PROJECT AND DRAWING

CLIENT: EPIC

CONSULTANT: HYOOSUNG

CONTRACTOR: HYOOSUNG

PROJECT: JIC